



MATCHLINE REFER TO DWG. P100

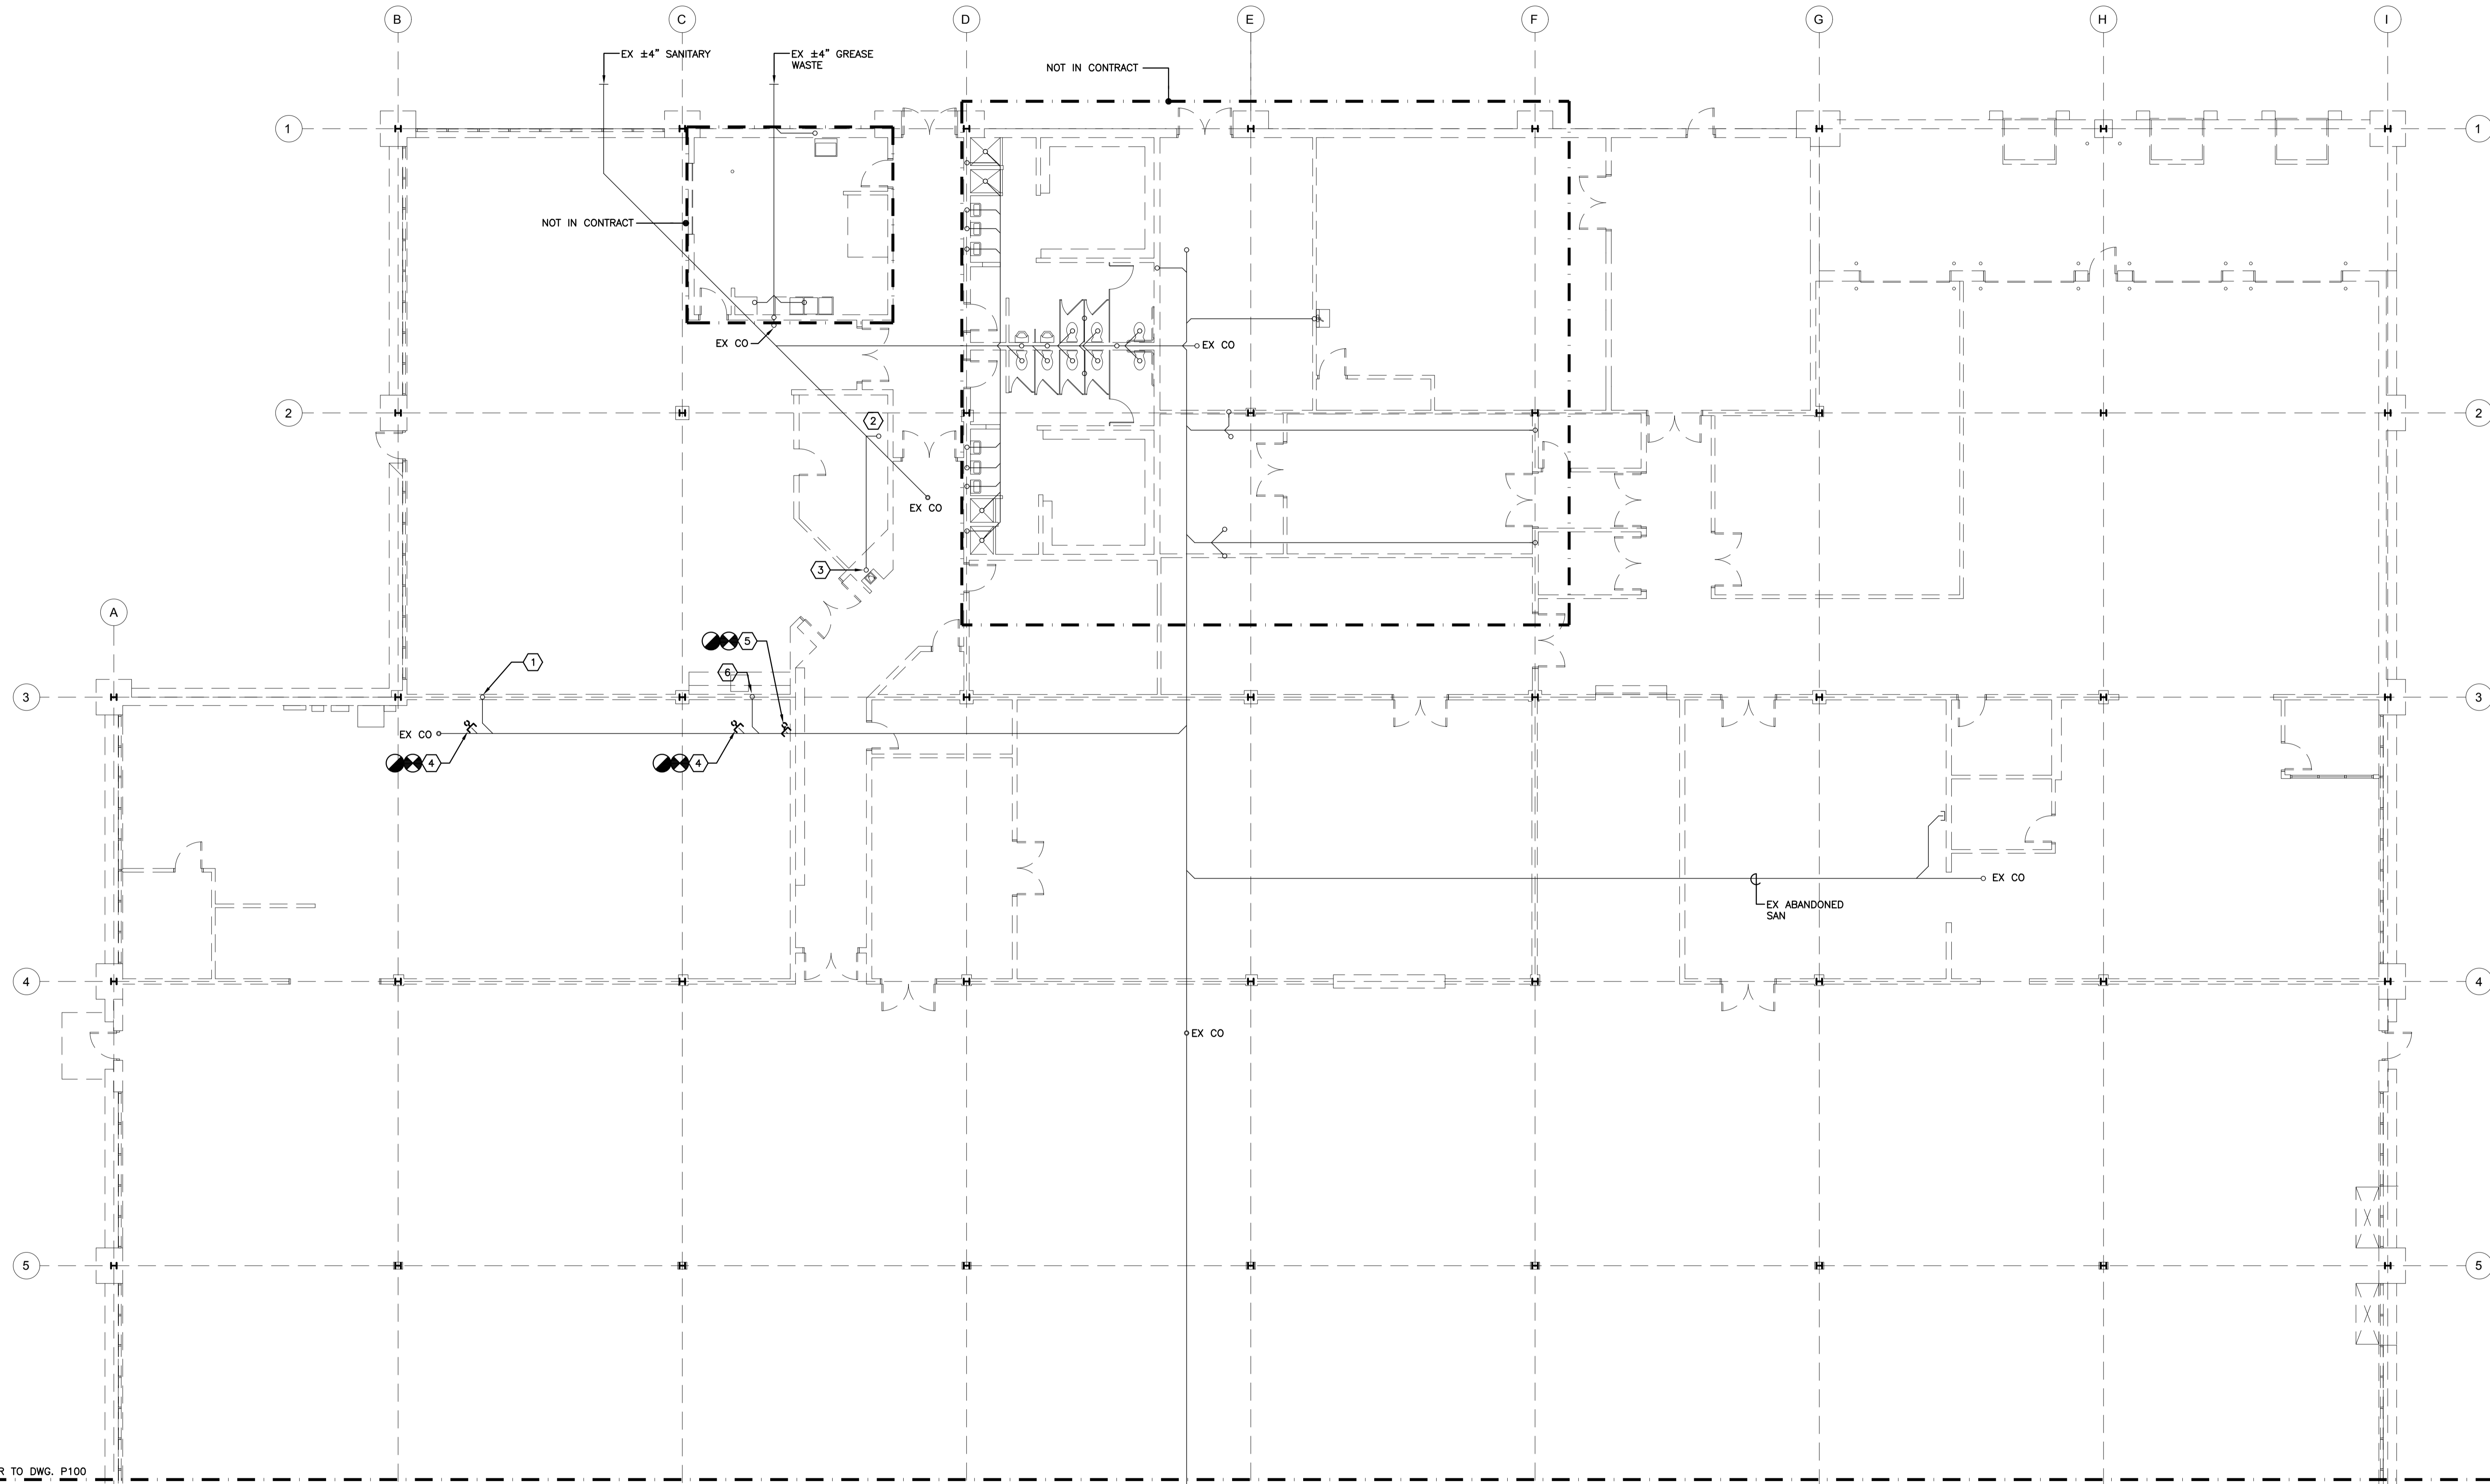

FOUNDATION PLAN - PLUMBING - DEMOLITION


SCALE: 1/8" = 1'-0"

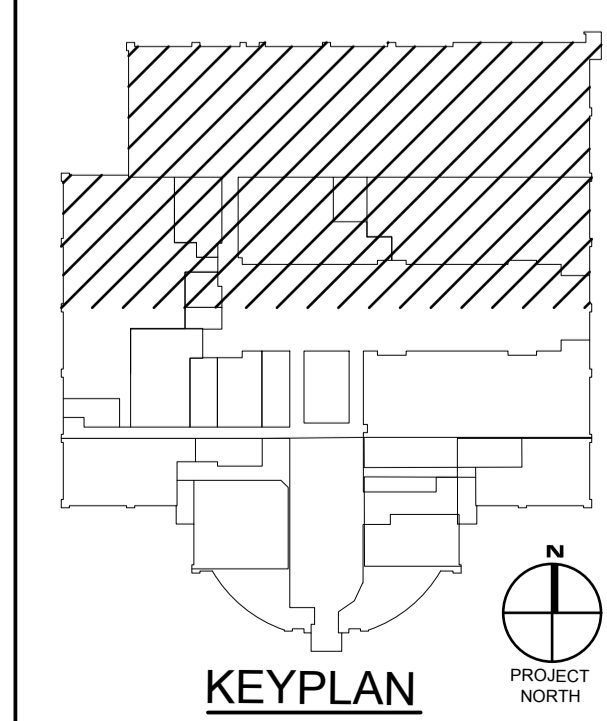

PRINT DATE: 11/01/10
 SPA PROJ. NO.: 2009/0264
 DESIGN BY: MW/C
 DRAWN BY: MW
 SCALE: AS NOTED
 STAGE: ISSUED FOR BIDS
 DWG. FILE: 09264P100.10

P
101
 SHEET: 18 OF 28
 ISSUED DATE: 11/01/10

**TRI - COUNTY COUNCIL
 REGIONAL CENTER
 ROUTE 50, EAST
 SALISBURY, MARYLAND**
 FOUNDATION PLAN - PLUMBING - DEMOLITION

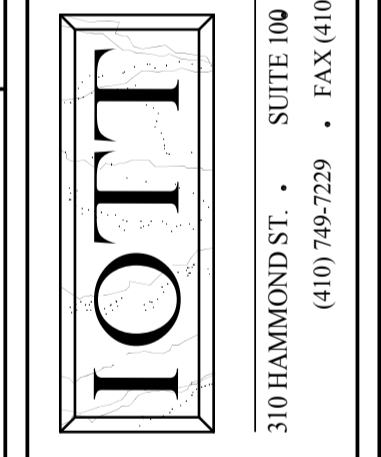

Professional Certification:
 These documents were
 prepared or approved by
 a duly licensed professional
 engineer under the laws
 of the State of Maryland,
 License No. 6987,
 Expiration Date:
 2012-08-14.

NO.	DATE	REMARKS	NO.	DATE	REMARKS

NO.	DATE	REMARKS	NO.	DATE	REMARKS