
 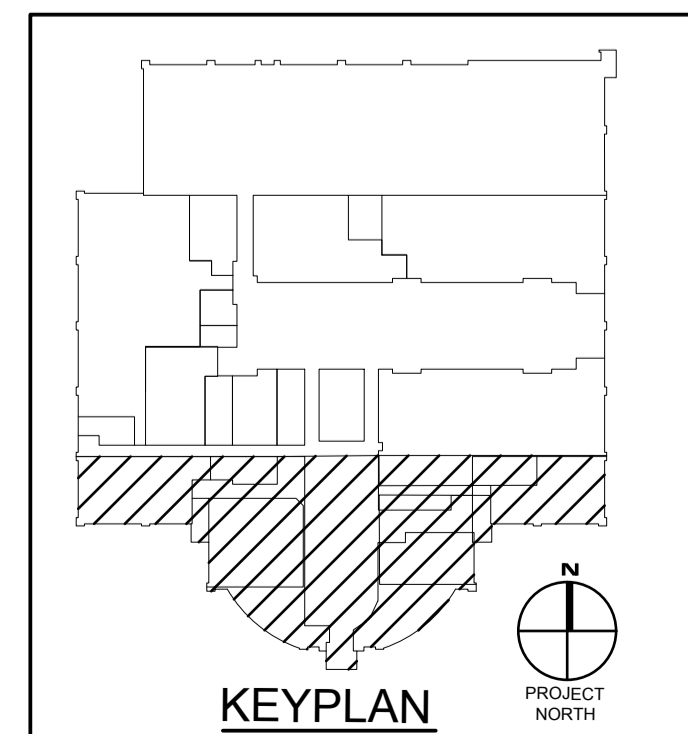


SECOND FLOOR PLAN - PLUMBING - DEMOLITION

SCALE: 1/8" = 1'-0"




PRINT DATE: 11/01/10
 SPA PROJ. NO.: 2009/0264
 DESIGN BY: MWTC
 DRAWN BY: TC/LMW
 SCALE: AS NOTED
 STAGE: ISSUED FOR BIDS
 DWG. FILE: 09264P104

P
104
 SHEET: 21 OF 28
 ISSUED DATE: 11/01/10

**TRI - COUNTY COUNCIL
 REGIONAL CENTER
 ROUTE 50, EAST
 SALISBURY, MARYLAND**

SECOND FLOOR PLAN - PLUMBING - DEMOLITION

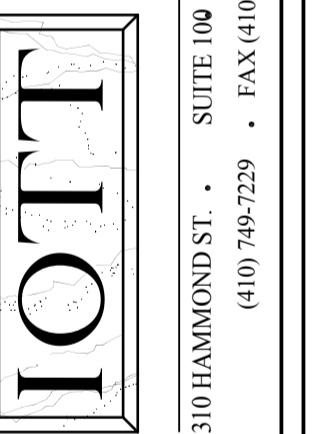

ARCHITECTURE
 ENGINEERING
 INCORPORATED
 SUITE 100
 310 HAMMOND ST.
 SALISBURY, MARYLAND
 (410) 746-7229 FAX (410) 746-0001

Professional Certification:
 These documents were
 prepared or approved by
 a duly licensed professional
 engineer under the laws
 of the State of Maryland.
 License No. 6997
 Expiration Date:
 2012-08-14

REVISIONS					
NO.	DATE	REMARKS	NO.	DATE	REMARKS